

APN: 007-021-21



22x34 SHEET: 1"=100'
11x17 SHEET: 1"=200'



A horizontal graphic scale bar with a black and white alternating pattern. It is marked with the numbers 0, 50, 100, and 200, representing feet.

[illegible]

NORTHPOINT
CONSULTING GROUP, INC.
1117 Samoa Blvd., Arcata, CA 95521

OSPREY FARM MAJOR USE PERMIT
255 BOGGS LN KELSEYVILLE, CA 95451
EXISTING AND PROPOSED SITE PLAN


PROJ. MGR.:	AD
DRAWN BY:	CJG
DATE:	04/07/25
SCALE:	AS SHOWN

C1

22-040



OSPREY FARM SECURITY PLAN

APN: 007-021-21

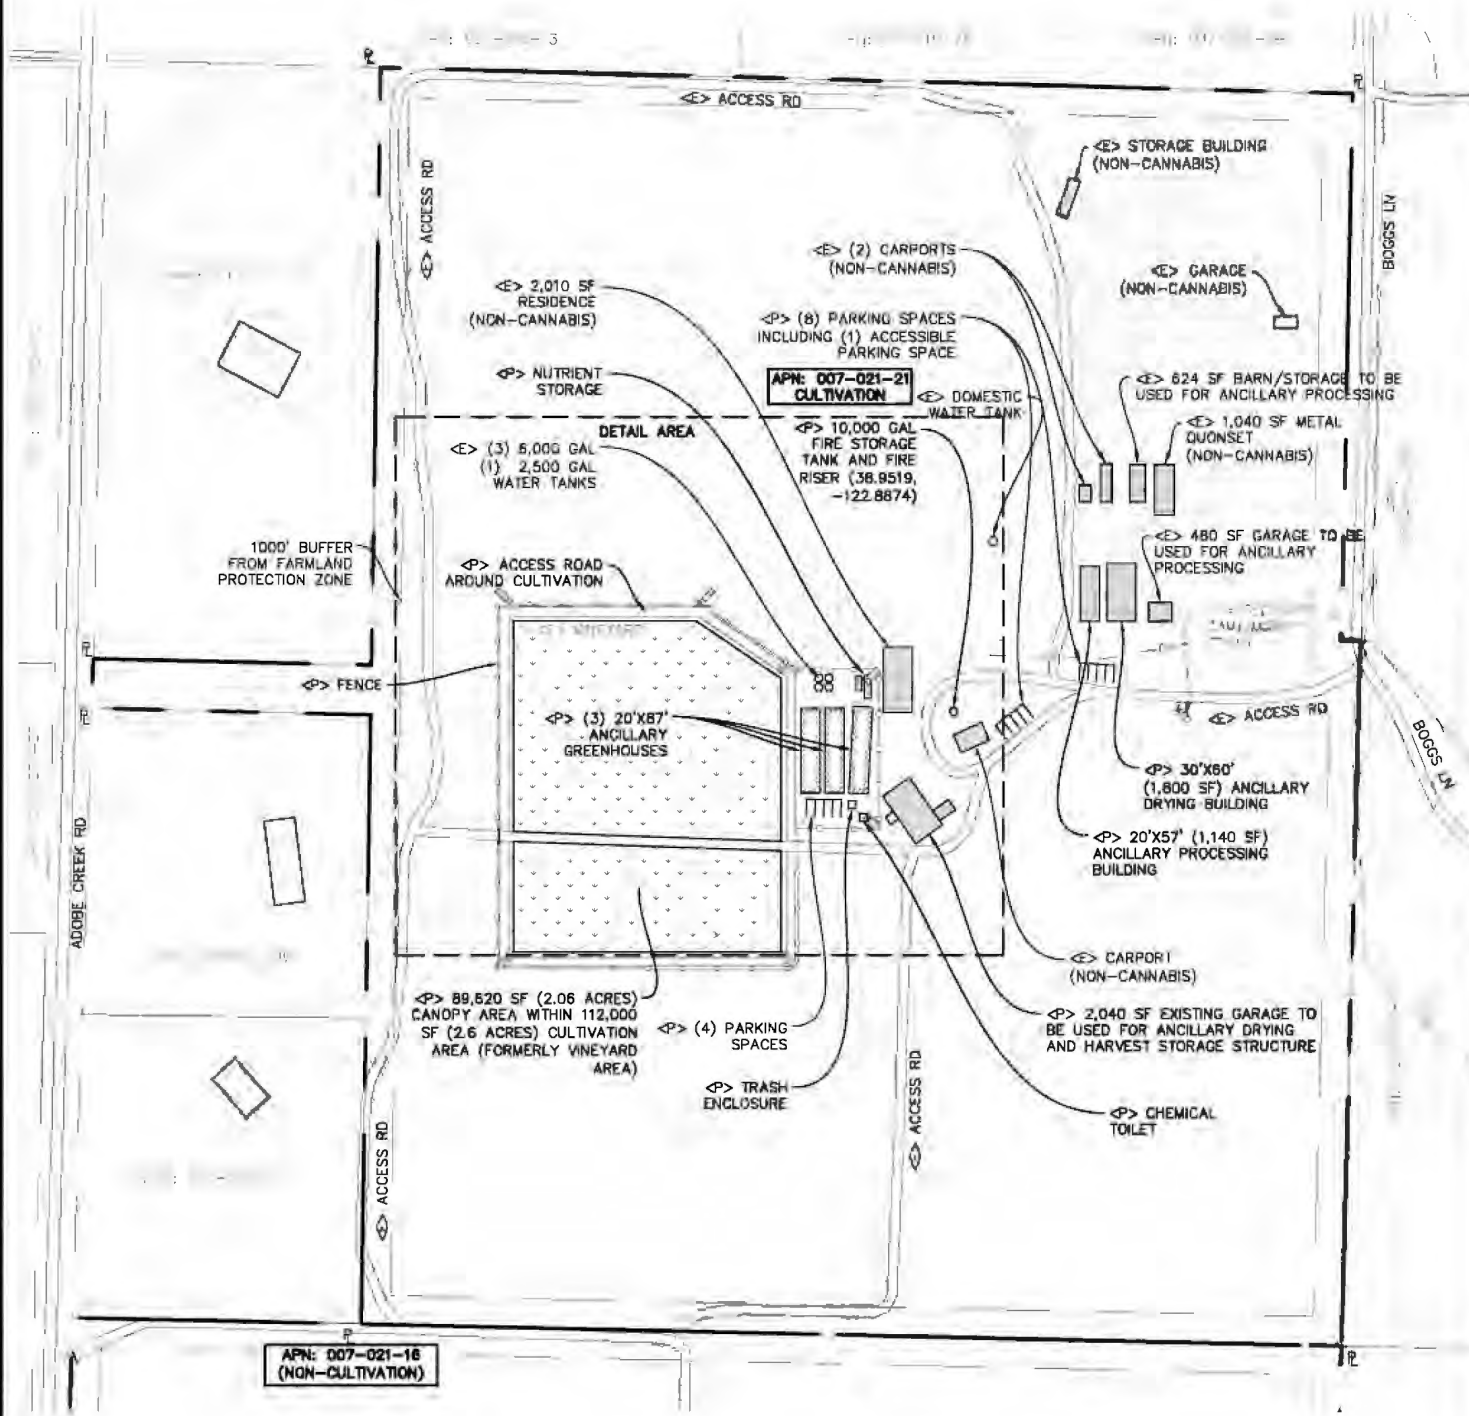

PLOT PLAN

 22x34 SHEET: 1"=100'
11x17 SHEET: 1"=200'

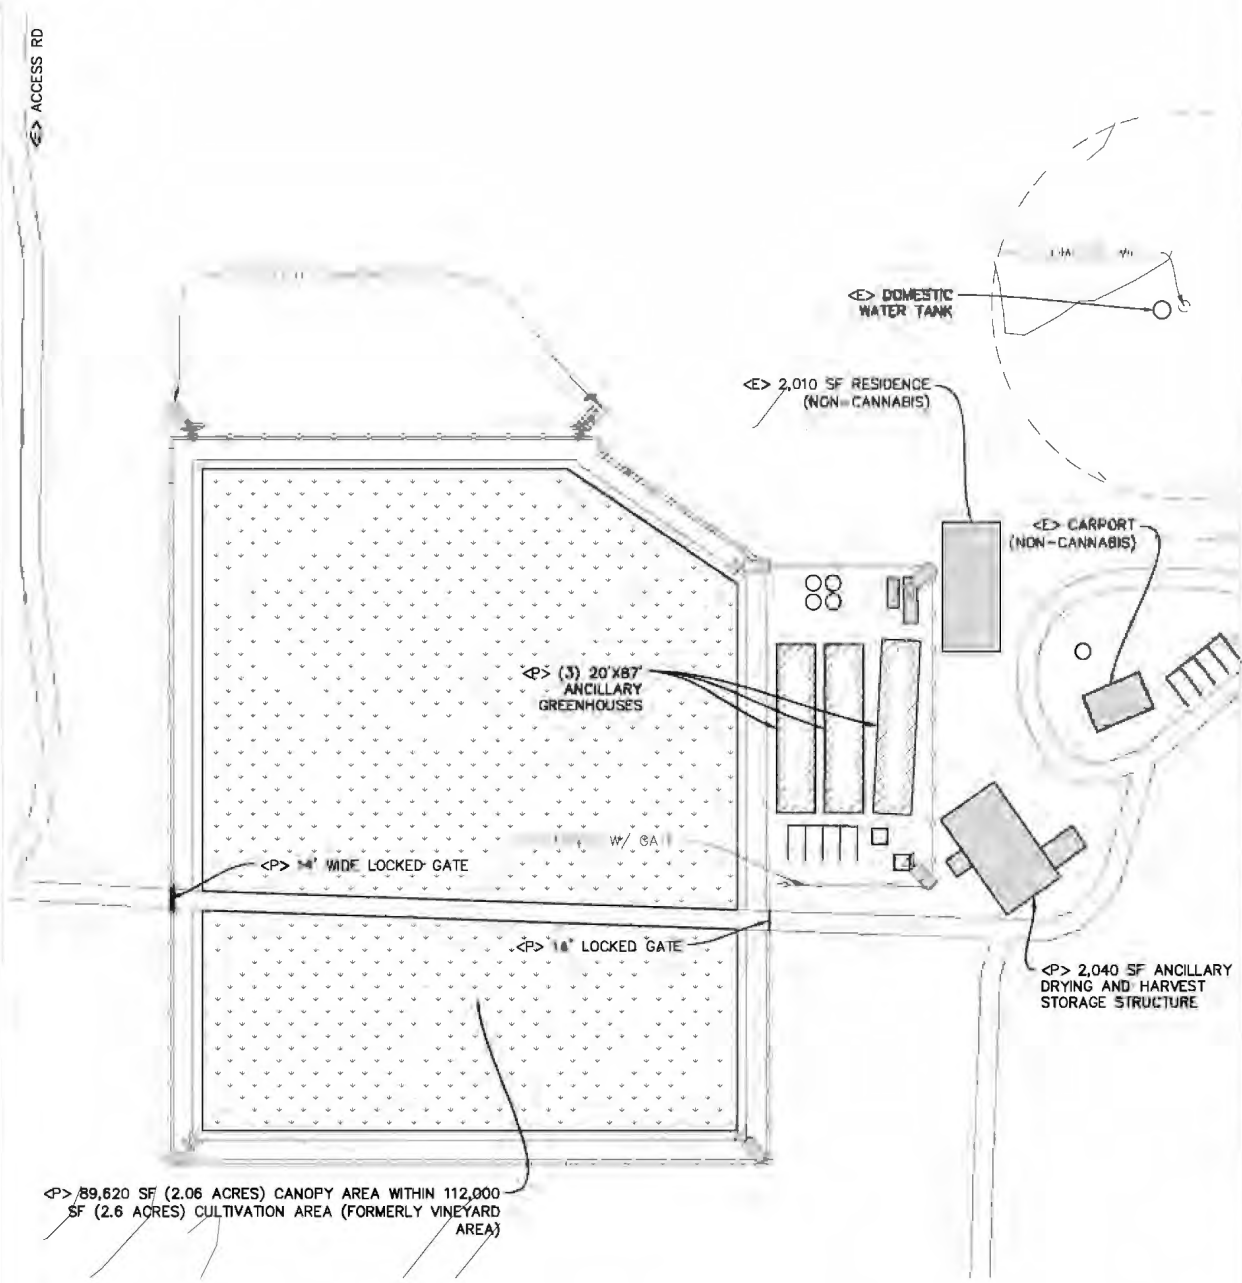


SECURITY LEGEND:

- MOTION SENSOR, LIGHTING AND SECURITY CAMERA
- FENCE
- GATE

DETAIL AREA

 22x34 SHEET: 1"=50'
11x17 SHEET: 1"=100'




NORTHPOINT
CONSULTING GROUP, INC.
1117 Samoa Blvd., Arcata, CA 95521

OSPREY FARM MAJOR USE PERMIT
7255 BOGGS LN KELSEVILLE, CA 95451
SECURITY PLAN

PROJ. NO.:
DRAWN BY: C.J.G.
DATE: 04/07/25
SCALE: AS SHOWN
SHEET

C2


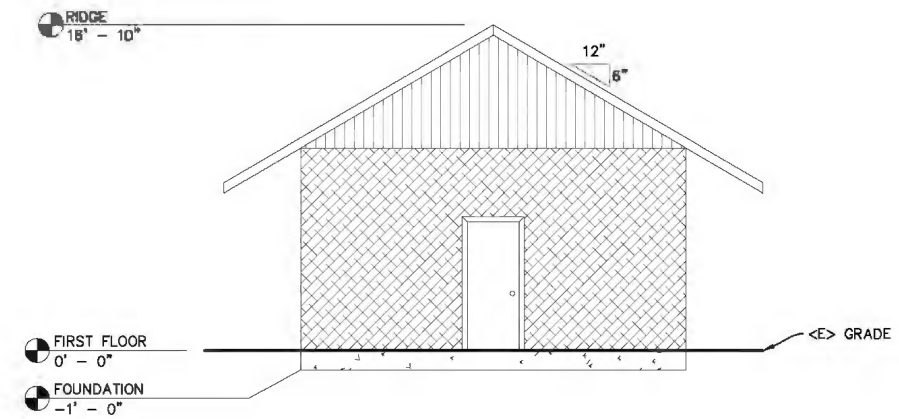


20'x57' ANCILLARY PROCESSING BUILDING - EAST / WEST ELEVATION

SCALE: 1"=5' (11X17 SHEET: 1"=10')

20'x57' ANCILLARY PROCESSING BUILDING NORTH / SOUTH ELEVATION

SCALE: 1"=5' (11X17 SHEET: 1"=10')

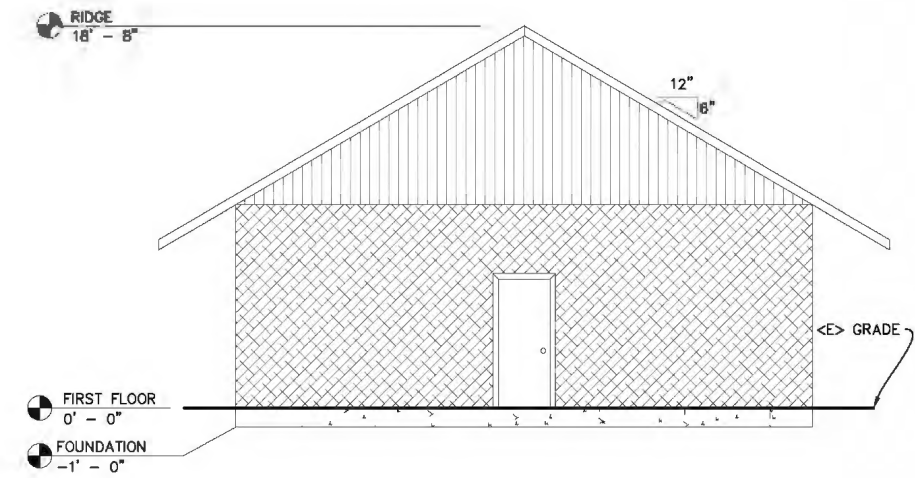
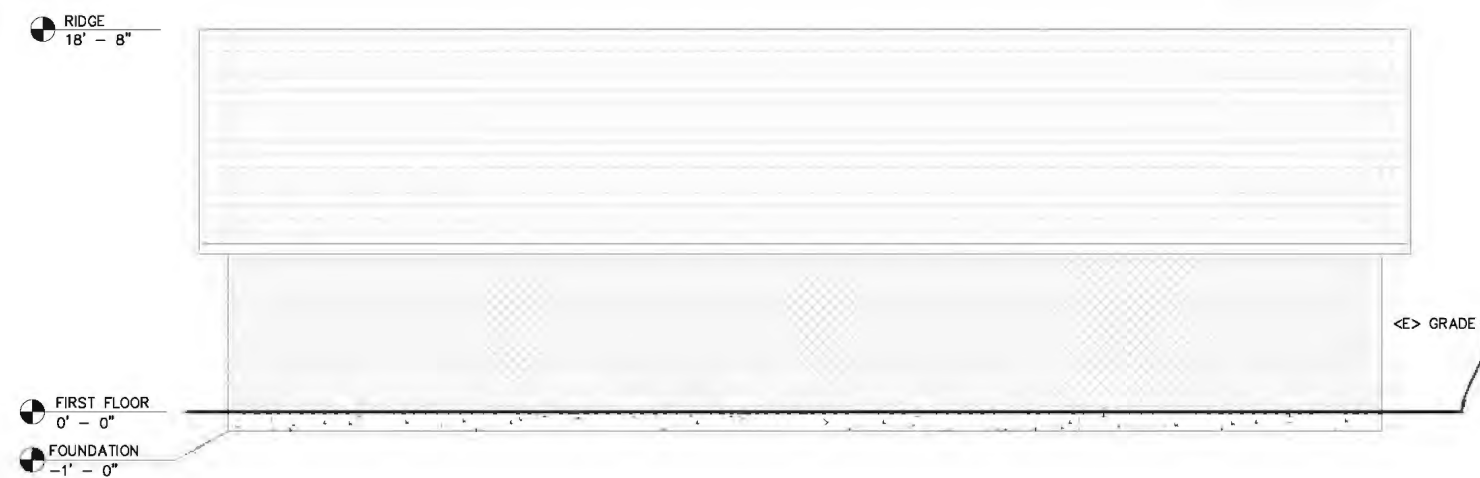


30'x60' DRYING BUILDING - EAST / WEST ELEVATION

SCALE: 1"=5' (11X17 SHEET: 1"=10')

30'x60' DRYING BUILDING NORTH / SOUTH ELEVATION

SCALE: 1"=5' (11X17 SHEET: 1"=10')

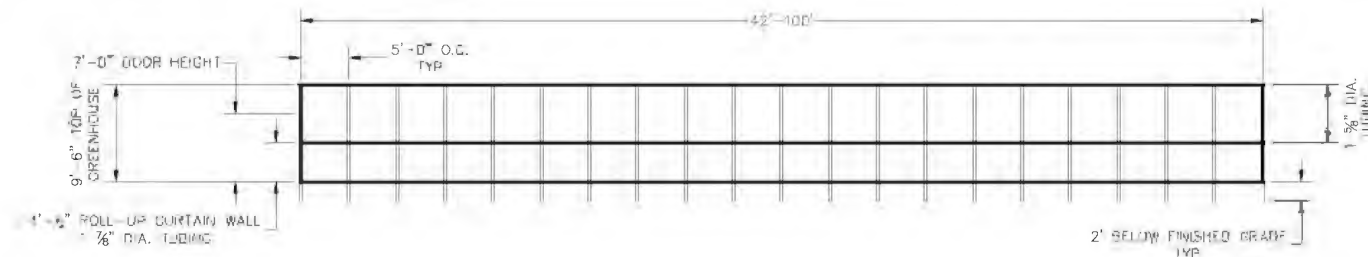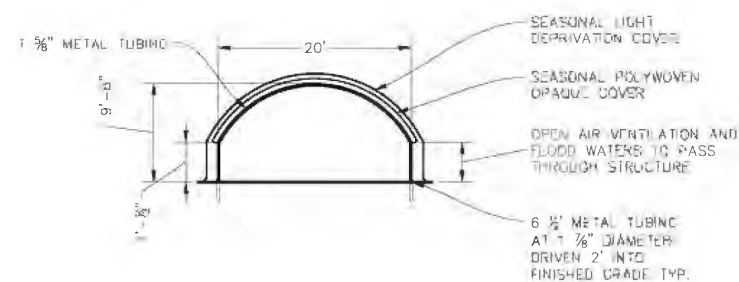

TYP. GREENHOUSE ELEVATIONS

~~NTS~~

[illegible]

NORTHPOINT
CONSULTING GROUP, INC.
1117 Samoa Blvd., Arcata, CA 95521

OSPREY FARM MAJOR USE PERMIT
7255 BOGGS LN KELSEYVILLE, CA 95455
BUILDING ELEVATIONS

PROJ. MGR:	AD
DRAWN BY:	
DATE:	04/07/25
SCALE:	AS SHOWN

SHEET

C3

22-040